






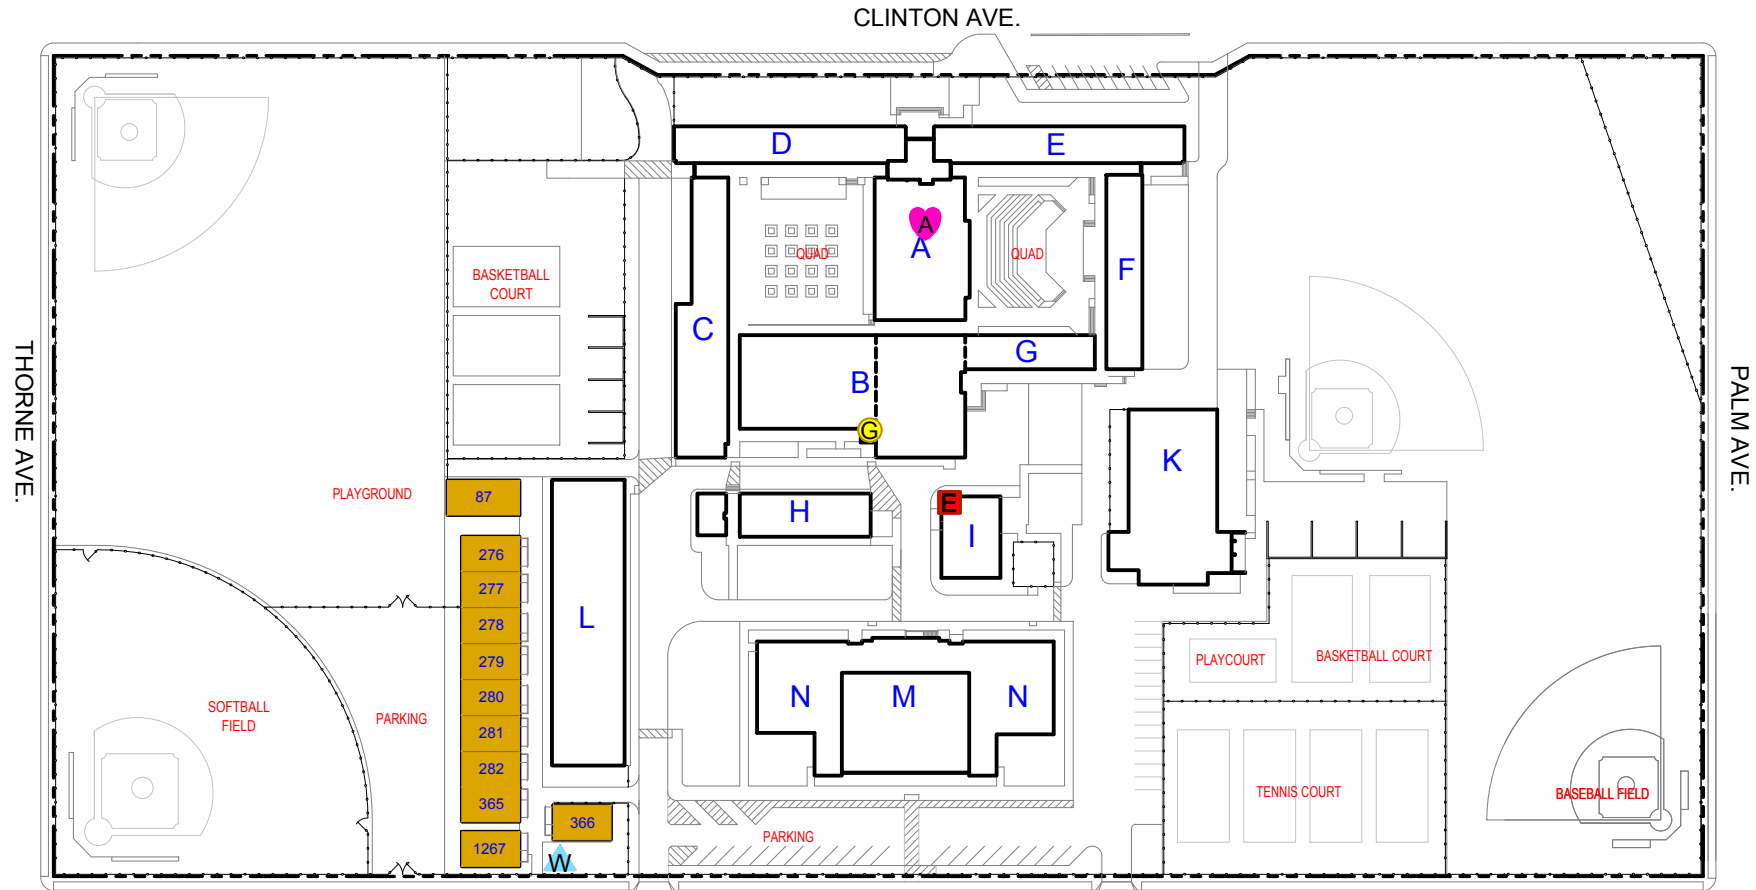


NORTH  **SITE PLAN KEY** W. UNIVERSITY AVE. SCALE: 1"=100'-0"
OVERALL SITE PLAN

LEGEND	
A	BUILDING CODE
PARKING	CODE
PCR #	PORTABLES
M.P.R.	DESCRIPTION

LEGEND	
	ELECTRICAL
	GAS
	WATER
	AED (Automated External Defibrillator)

FREMONT ELEMENTARY SCHOOL		
1005 W. WELDON AVENUE		
FRESNO, CALIFORNIA		
DATE:	PROPERTY:	SHEET:
04-18-18	#175	1 of 5




SITE PLAN KEY

OVERALL SITE PLAN

LEGEND	
EMERGENCY UTILITY SHUT-OFFS	
	- ELECTRICAL
	- GAS
	- WATER
	- AED (Automated External Defibrillator)

HAMILTON K - 8 SCHOOL		
102 E. CLINTON AVENUE		
FRESNO, CALIFORNIA		
DATE:	PROPERTY:	SHEET:
04-18-18	#206	2 of 5



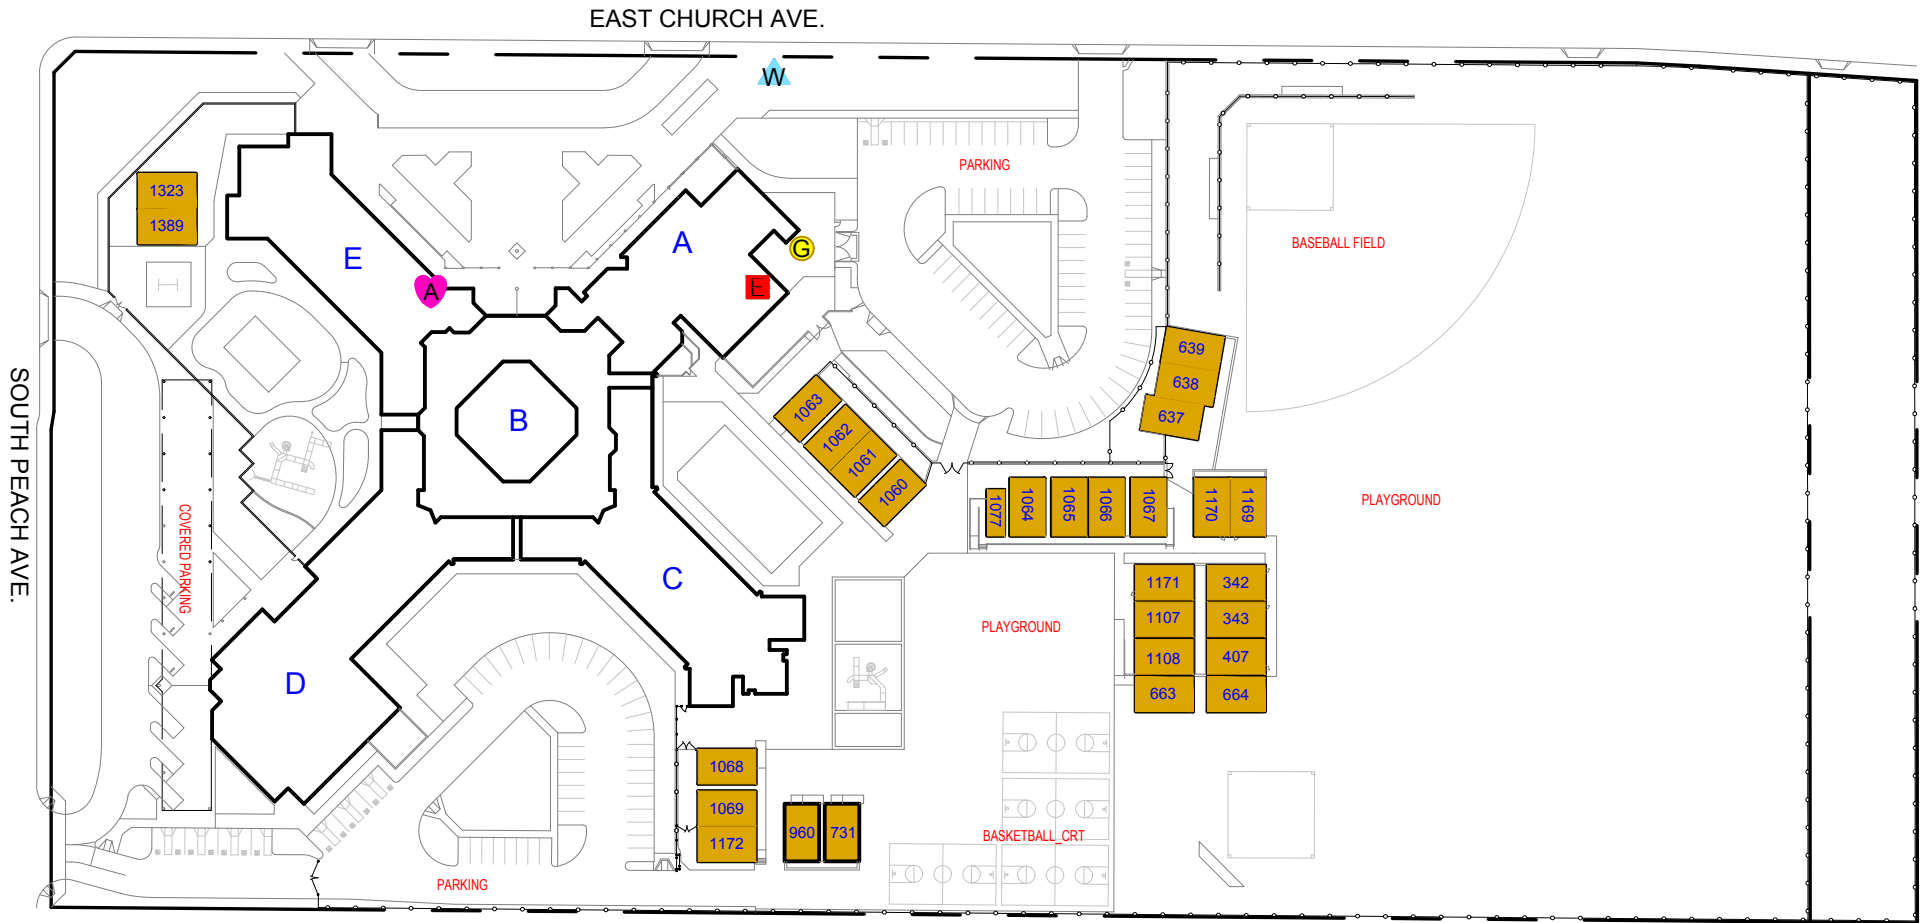

SITE PLAN KEY


OVERALL SITE PLAN

LEGEND	
A	BUILDING CODE
P	PARKING CODE
PCR #	PORTABLES
M.P.R.	DESCRIPTION

LEGEND	
E	- ELECTRICAL
G	- GAS
W	- WATER
A	- AED (Automated External Defibrillator)

STOREY ELEMENTARY SCHOOL		
5250 E. CHURCH AVENUE		
FRESNO, CALIFORNIA		
DATE: 04-23-18	PROPERTY: #430	SHEET: 3 of 5

NORTH MAPLE AVENUE

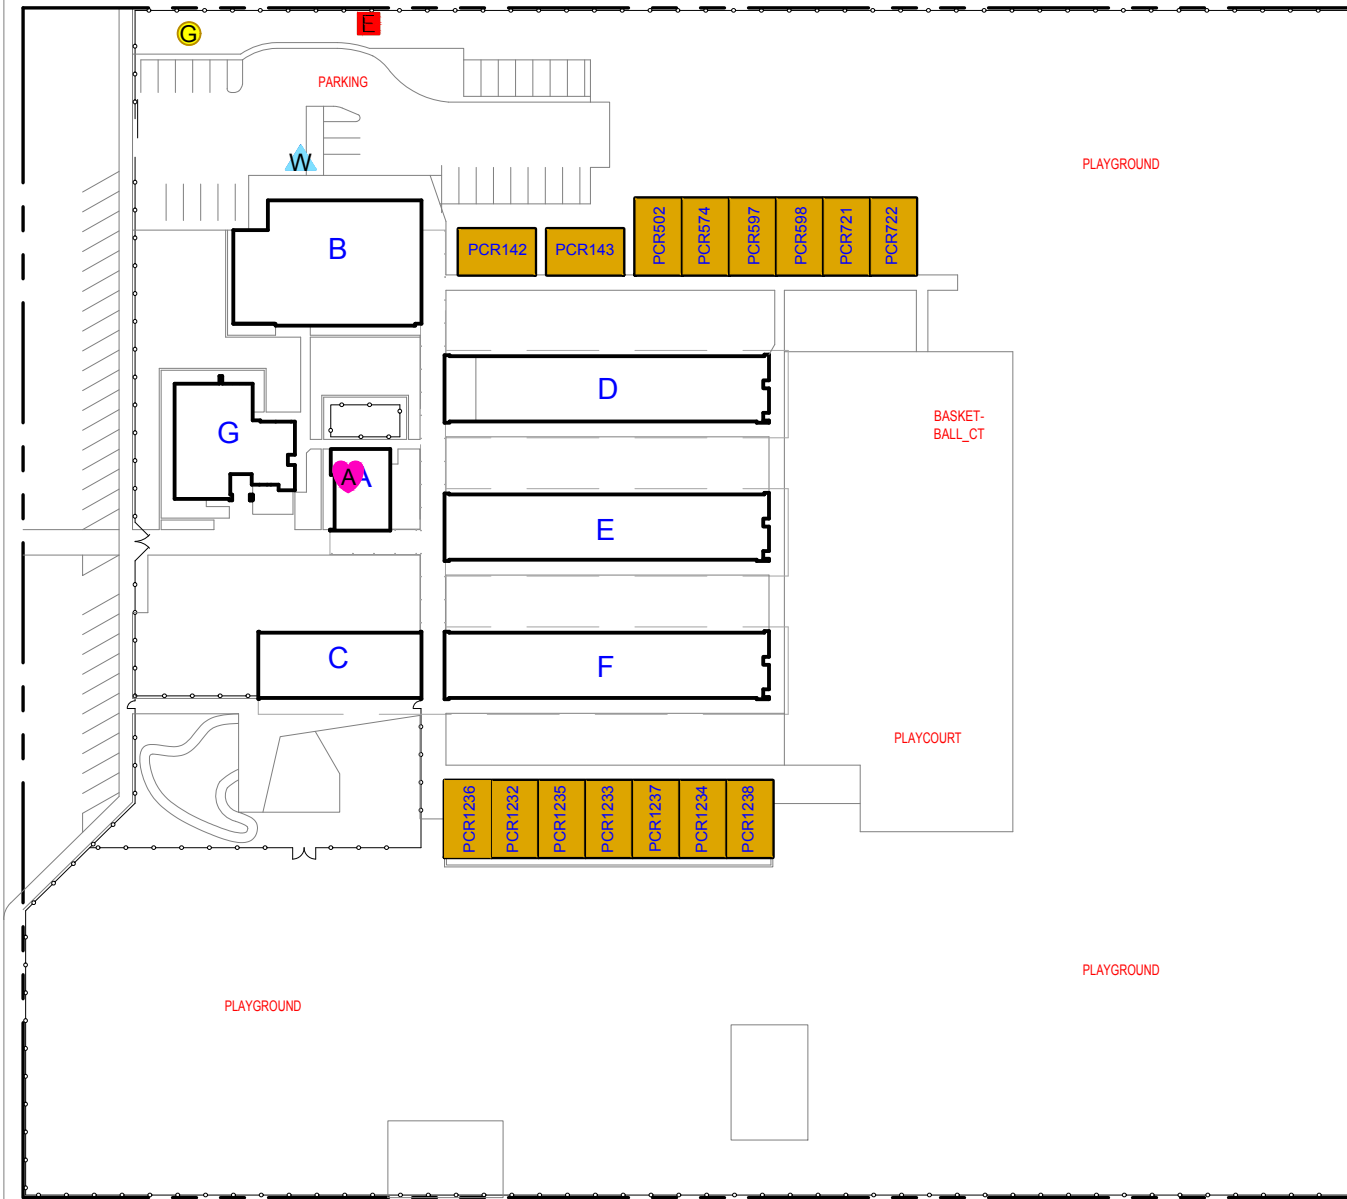

GETTYSBURG AVENUE



SITE PLAN KEY
OVERALL SITE PLAN

LEGEND
EMERGENCY UTILITY SHUT-OFFS


- - ELECTRICAL
- G - GAS
- W - WATER
- A - AED (Automated External Defibrillator)

LEGEND

- A - BUILDING CODE
- PARKING - CODE
- PCR # - PORTABLES
- M.P.R. - DESCRIPTION

VINLAND ELEMENTARY SCHOOL		 Fresno Unified School District
4666 N. MAPLE AVENUE		
FRESNO, CALIFORNIA		
DATE: 04-23-18	PROPERTY: #470	SHEET: 4 of 5

FLORADORA AVE

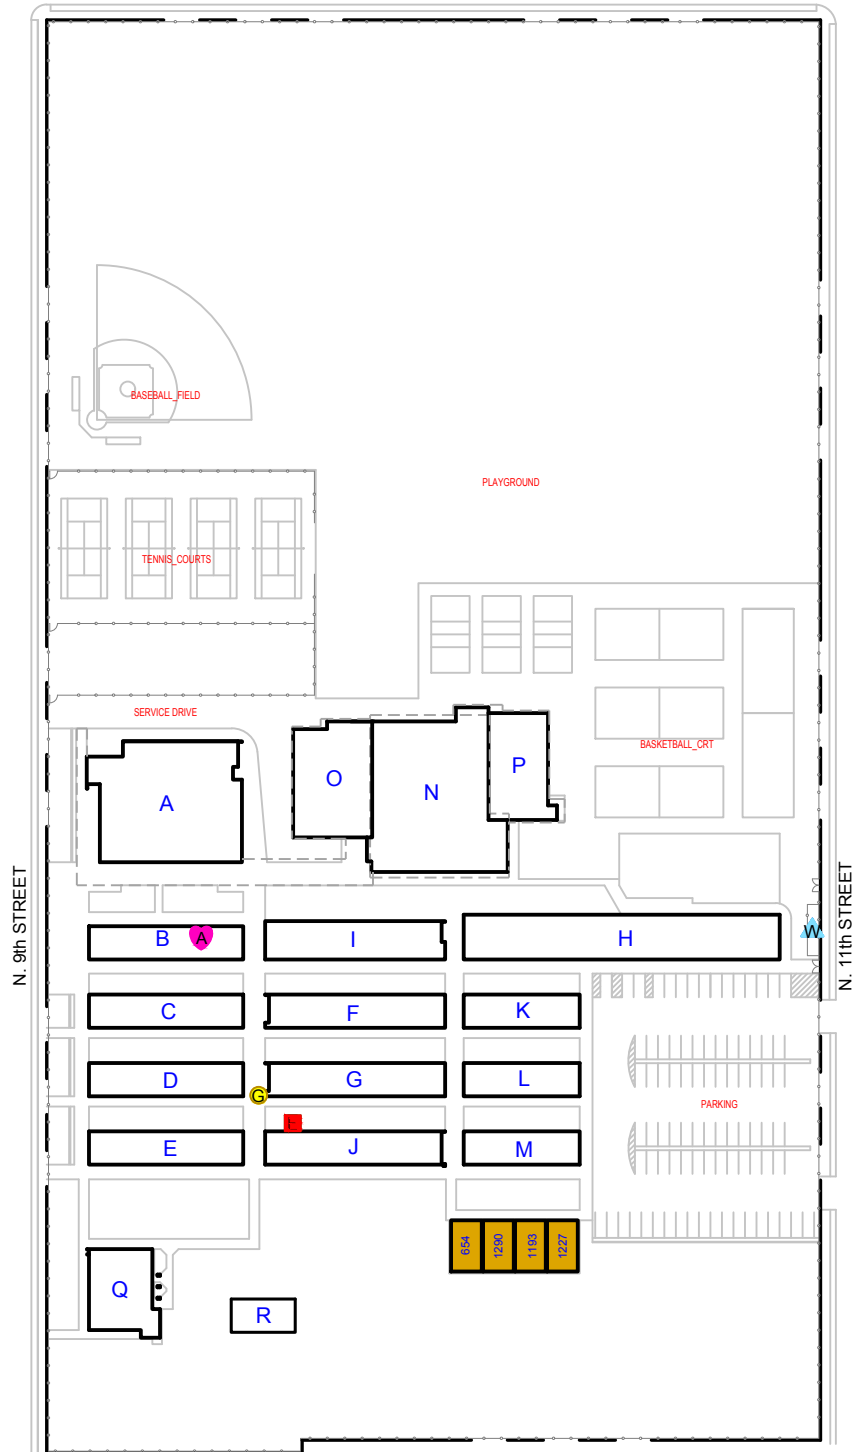

LEGEND

EMERGENCY UTILITY SHUT-OFFS

- - ELECTRICAL
- - GAS
- W - WATER
- ♥ - AED (Automated External Defibrillator)

LEGEND

- A - BUILDING CODE
- PARKING - CODE
- PCR # - PORTABLES
- M.P.R. - DESCRIPTION



SITE PLAN KEY

OVERALL SITE PLAN

YOSEMITE
MIDDLE SCHOOL
1292 N. NINTH STREET
FRESNO, CALIFORNIA



DATE:	PROPERTY:	SHEET:	
03-13-18	#505	5 of 5	